

NOTES:


- ALL DIMENSIONS ARE IN METRES UNLESS OTHERWISE STATED.
- FOR LIGHTING LAYOUT, REFER DRAWING NOS. 5230536-ATR-HLG-XX-DR-EO-000001 TO 5230536-ATR-HLG-XX-DR-EO-000004
- FOR DRAINAGE LAYOUT, REFER DRAWING NOS. 5230536-ATR-HDG-XX-DR-CH-000505 TO 5230536-ATR-HDG-XX-DR-CH-000508
- FOR PAVEMENT TREATMENT, REFER DRAWING NOS. 5230536-ATR-HPV-XX-DR-CH-000705 TO 5230536-ATR-HPV-XX-DR-CH-000708
- FOR KERBS & FOOTWAY LAYOUT, REFER DRAWING NOS. 5230536-ATR-HKF-XX-DR-CH-001101 TO 5230536-ATR-HKF-XX-DR-CH-001104
- FOR KERBS STANDARD DETAILS, REFER DRAWING NOS. 5230536-ATR-HKF-XX-DR-CH-001106
- FOR ROAD MARKINGS LAYOUT, REFER DRAWING NOS. 5230536-ATR-HMK-XX-DR-CH-001204
- FOR TRAFFIC SIGNS LAYOUT, REFER DRAWING NOS. 5230536-ATR-HSN-XX-DR-CH-001201 TO 5230536-ATR-HSN-XX-DR-CH-001203
- ALL THE PROPOSED ROAD MARKINGS TO BE AS PER TSRGD 2016 AND SUBSEQUENT AMENDMENTS, AND LATEST REVISION OF TRAFFIC SIGNS MANUALS.

KEY:

- PROPOSED DUTCH KERB
- PROPOSED CARRIAGEWAY / CAR PARK
- CARRIAGEWAY WIDENING
- EXISTING FOOTWAY RESURFACING
- PROPOSED PATH
- FOOTWAY WIDENING
- PROPOSED BUFFER
- PROPOSED SHARED USE
- PROPOSED PAVED ISLAND
- PROPOSED LOADING / PARKING BAY
- PROPOSED CYCLE PARKING
- PROPOSED BUS SHELTER
- PROPOSED LANDSCAPING FEATURES
- PROPOSED RAMP
- PROPOSED BENCH
- PROPOSED BOLLARD
- PROPOSED TRAFFIC SIGN FACE, POST & FOUNDATION
- PROPOSED LOCATION OF THE RELOCATED SIGN FACE ON NEW POST & FOUNDATION
- EXISTING TRAFFIC SIGN FACE & POST TO BE RETAINED
- PROPOSED ILLUMINATED TRAFFIC SIGN FACE

- PROPOSED GUARDRAIL
- PROPOSED KERB
- EXISTING ROAD KERB TO BE RETAINED (E1ex,YORKSTONE)
- PROPOSED ROAD MARKING
- EXISTING ROAD MARKING
- PROPOSED TACTILE PAVING (UNCONTROLLED CROSSING - BUFF COLOUR)
- PROPOSED TACTILE PAVING (CONTROLLED CROSSING - RED COLOUR)
- PROPOSED CORDUROY PAVING
- PROPOSED CARRIAGEWAY GULLY
- PROPOSED FOOTWAY GULLY
- PROPOSED FLAT DRAINAGE CHANNEL
- EXISTING CARRIAGEWAY GULLY TO REMAIN
- EXISTING FOOTWAY GULLY TO REMAIN
- EXISTING GULLY AND DOWNPIPE TO REMAIN
- EXISTING LINEAR CHANNEL TO REMAIN
- PROPOSED STEEL LIGHTING COLUMNS
- EXISTING 6, 10 AND 12M COLUMNS TO RETAINED RESPECTIVELY
- EXISTING FEEDER PILLAR RETAINED
- EXISTING DECORATIVE LIGHTING RETAINED
- HAZARD WARNING TRIANGLE
- SITE EXTENT

- ALL THE PROPOSED ROAD MARKINGS TO BE TIED IN TO EXISTING MARKING AS DIRECTED BY THE ENGINEER.
- FOR TRAFFIC SIGNAL PROPOSAL, REFER TO LCC TRAFFIC SIGNAL DRAWING.
- DRAWING SHALL BE READ IN CONJUNCTION WITH 200, 500, 700, 1100, 1200, 1300, & 1400 SERIES OF SPECIFICATIONS.
- IN ADDITION TO THE HAZARDS/ RISKS NORMALLY ASSOCIATED WITH THE TYPE OF WORKS DETAILED ON THIS DRAWING TAKE NOTE OF THE RESIDUAL DESIGN HAZARDS IN THE SHE BOX TO THE RIGHT. IT IS ASSUMED THAT ALL WORKS ON THIS DRAWING WILL BE CARRIED OUT BY A COMPETENT CONTRACTOR WORKING, WHERE APPLICABLE, TO AN APPROPRIATE METHOD STATEMENT.

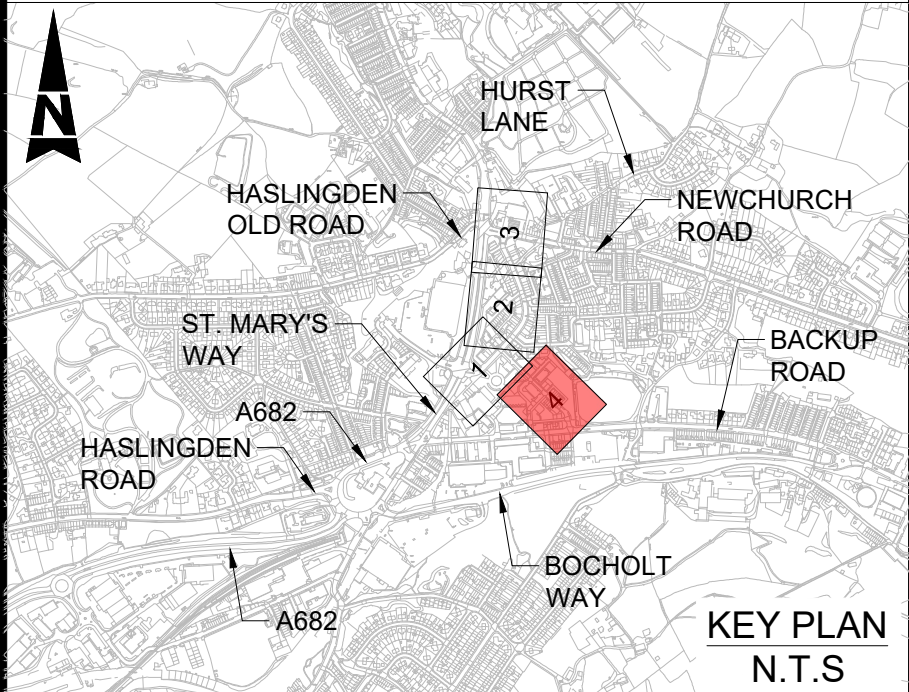

SAFETY, HEALTH AND ENVIRONMENTAL INFORMATION

In addition to the hazards/risks normally associated with the types of work detailed on this drawing, note the following significant residual risks (Reference shall also be made to the design hazard log).

Construction
1.ELECTRIC CABLES 2.GAS LINE 3.WATER MAINS 4.UNDERGROUND TELECOMMUNICATION 5.TV CABLE 6.UNIDENTIFIED UTILITIES
Maintenance / Cleaning
1.ELECTRIC CABLES 2.GAS LINE 3.WATER MAINS 4.UNDERGROUND TELECOMMUNICATION 5.TV CABLE 6.UNIDENTIFIED UTILITIES
Use
None

Decommissioning / Demolition
1.ELECTRIC CABLES 2.GAS LINE 3.WATER MAINS 4.UNDERGROUND TELECOMMUNICATION 5.TV CABLE 6.UNIDENTIFIED UTILITIES

Description						
Status	Revision	Drawn	Checked	Reviewed	Authorised	Issue Date
Description						
Status	Revision	Drawn	Checked	Reviewed	Authorised	Issue Date
Description						
Status	Revision	Drawn	Checked	Reviewed	Authorised	Issue Date
Description						
Status	Revision	Drawn	Checked	Reviewed	Authorised	Issue Date
Description						
FIRST ISSUE						
Status	Revision	Drawn	Checked	Reviewed	Authorised	Issue Date
A1	C01	AK	JB	PC	JM	11/12/24

Status	Drawing Suitability
A1	AUTHORISED & ACCEPTED

AtkinsRéalis	Chadwick House Birchwood Park Warrington WA3 6AE Tel: +44 (0)1925 238000 Fax: +44 (0)1925 238500 Copyright © AtkinsRéalis (2024) www.AtkinsRealis.com
--------------	---

Client	Lancashire County Council
--------	---------------------------------

Project Stage / Design File	State
-----------------------------	-------

Project Title	BANK STREET LUF
---------------	-----------------

Drawing Title	GENERAL ARRANGEMENT (SHEET 4 OF 4)
---------------	---------------------------------------

Drawing Number	Project	Originator	Volume
5230536	- ATK - HGN -		
XX	- DR - CH -	000104	
Location	Type	Role	Number
Original Size: A1	Scale: 1:250	Project Ref. No: 5230536	Sheet: 4 of 4 Rev: C01

FOR CONTINUATION SEE DRAWING NO. 5230536-ATR-HGN-XX-DR-CH-000102

Based on Ordnance Survey mapping with the permission of the Controller of His Majesty's Stationery Office. © Crown copyright. Unauthorised reproduction infringes Crown copyright and may lead to prosecution or civil proceedings. Lancashire County Council Licence No. LA10002320.

